


NOTE: TO ORIGINAL DRAWINGS FOR SITE LIGHTING CONNECTED TO PANEL PP-1

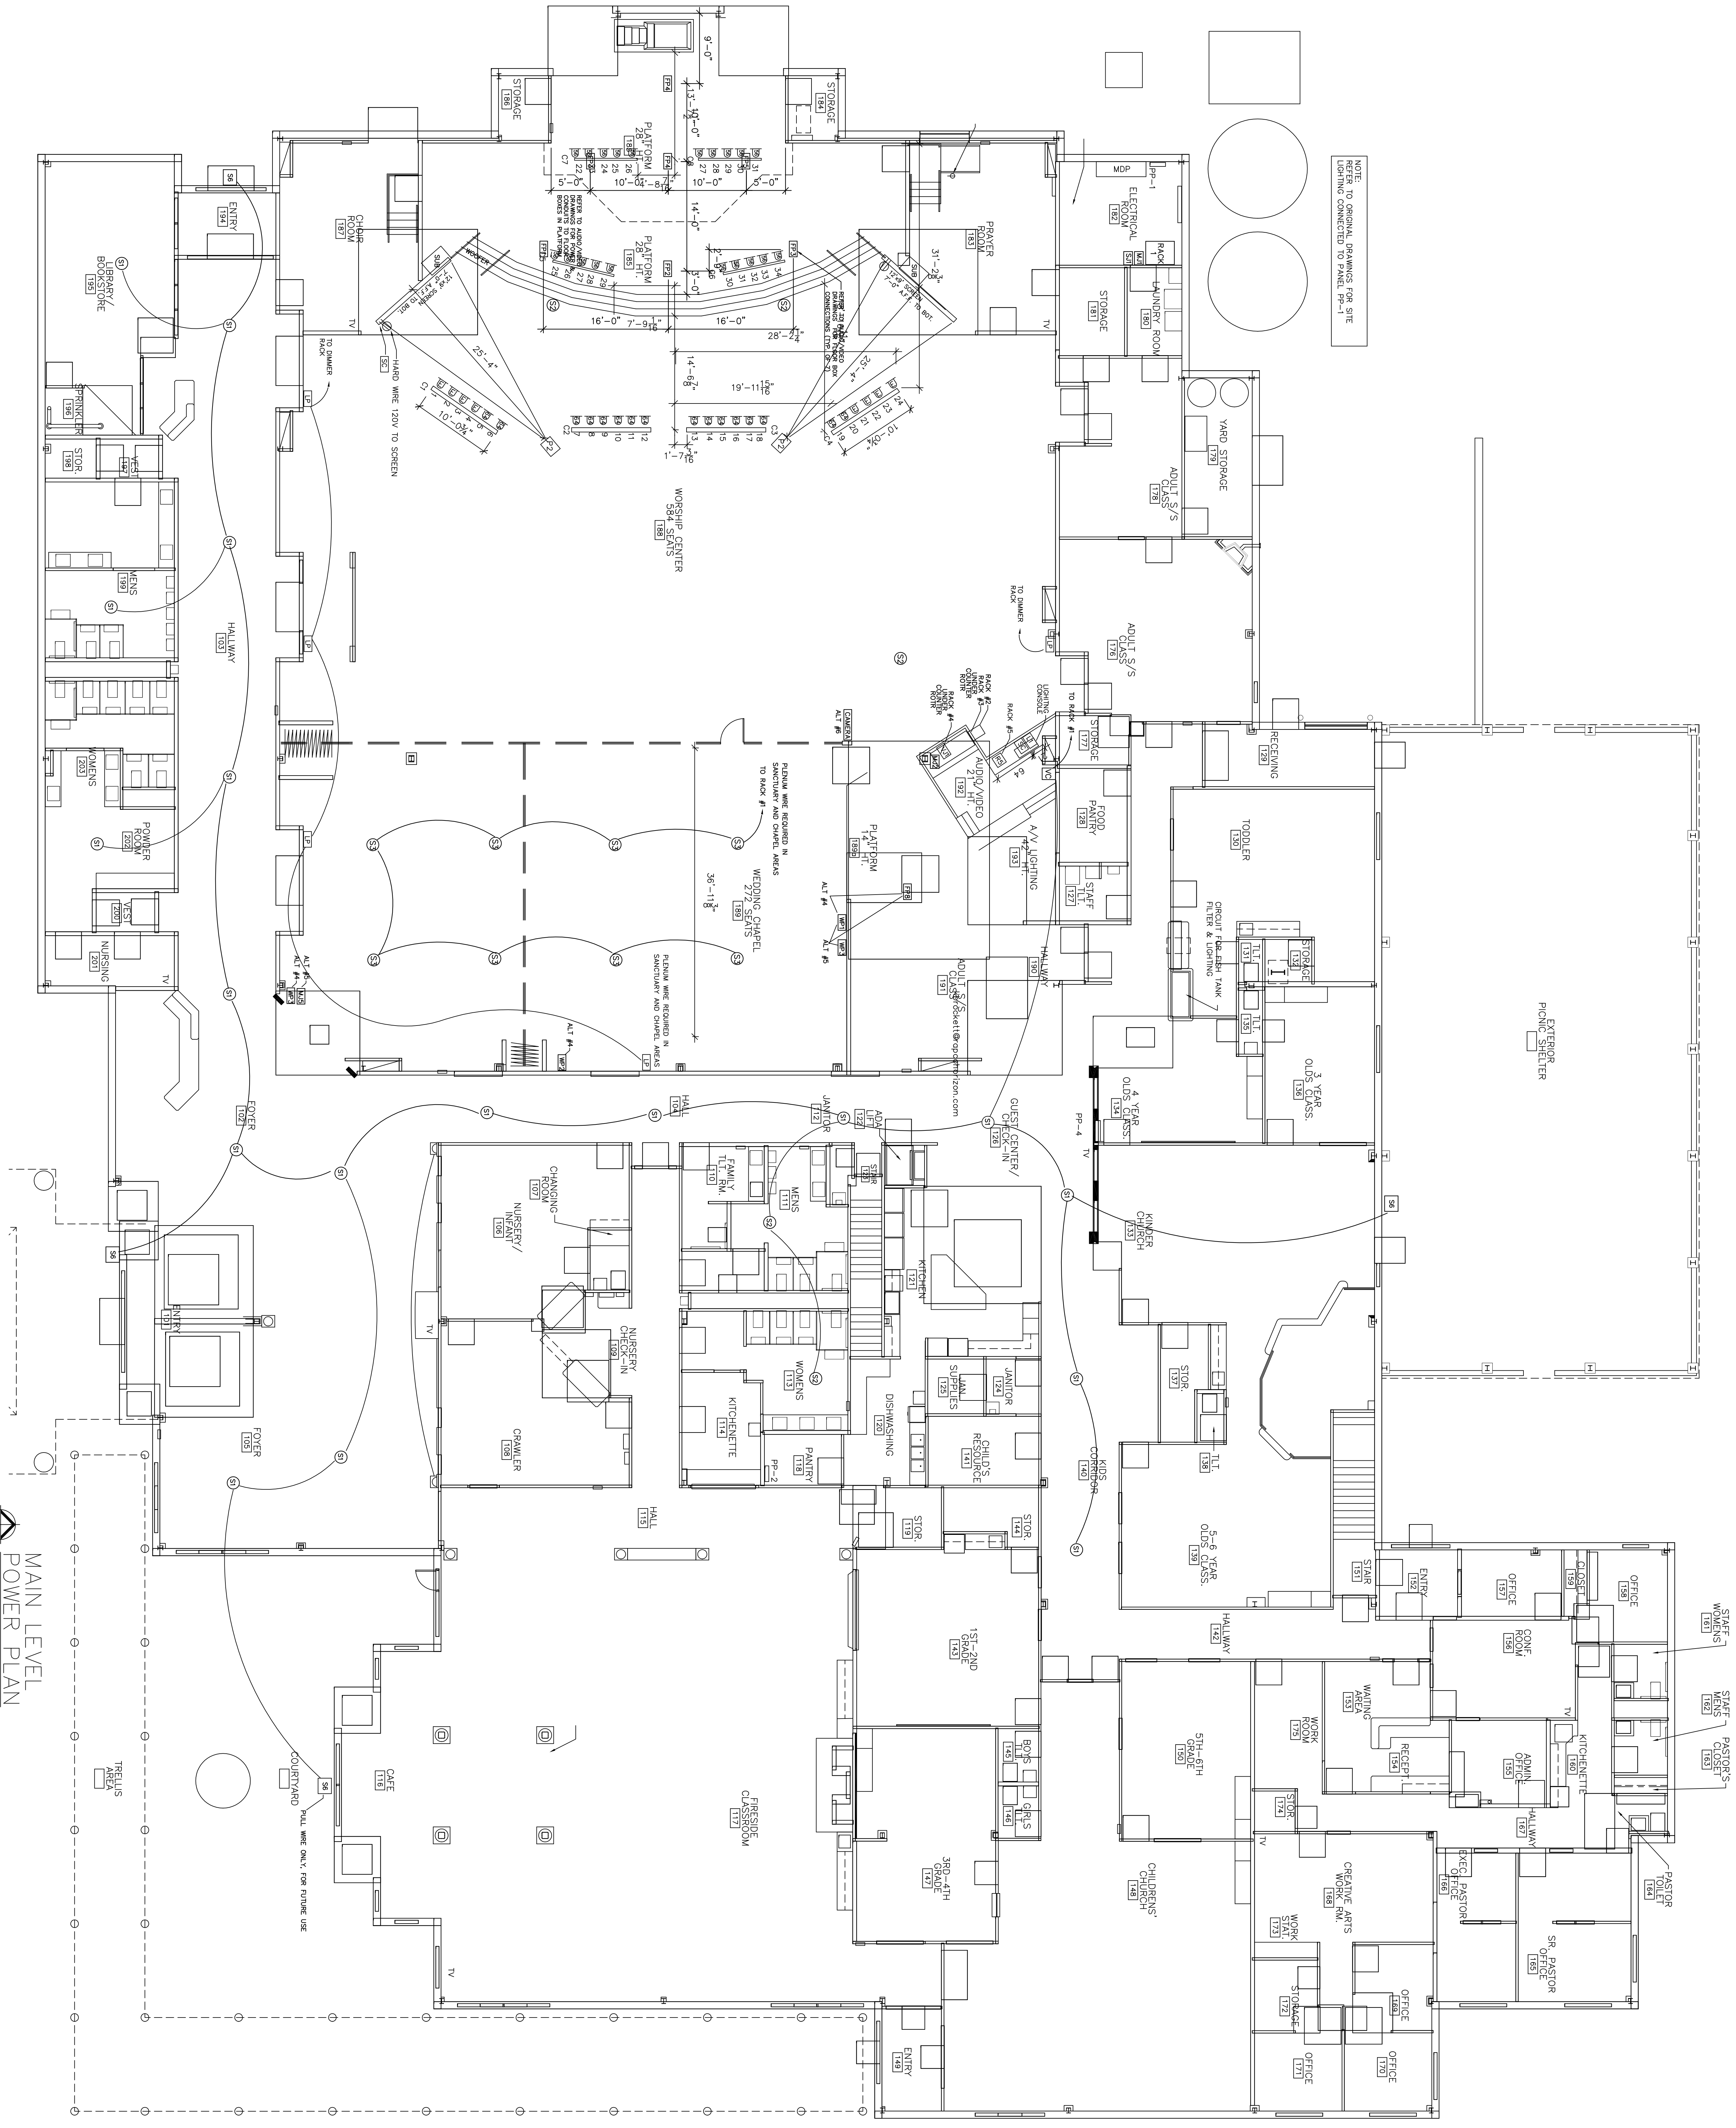

MAIN LEVEL
POWER PLAN
SCALE: 1/8" = 1'-0"